



9'0" FINISHED CEILING HEIGHT ON FIRST FLOOR
 1'4" WINDOW HEADER HEIGHT ON FIRST FLOOR
 8'0" FINISHED CEILING HEIGHT ON SECOND FLOOR
 6'8" WINDOW HEADER HEIGHT ON SECOND FLOOR

FRONT ELEVATION
 SCALE: 1/4" = 1'0"


ATTIC VENTILATION - $4685 \text{ S/F} / 300 = 15.61 \text{ S/F REQUIRED}$

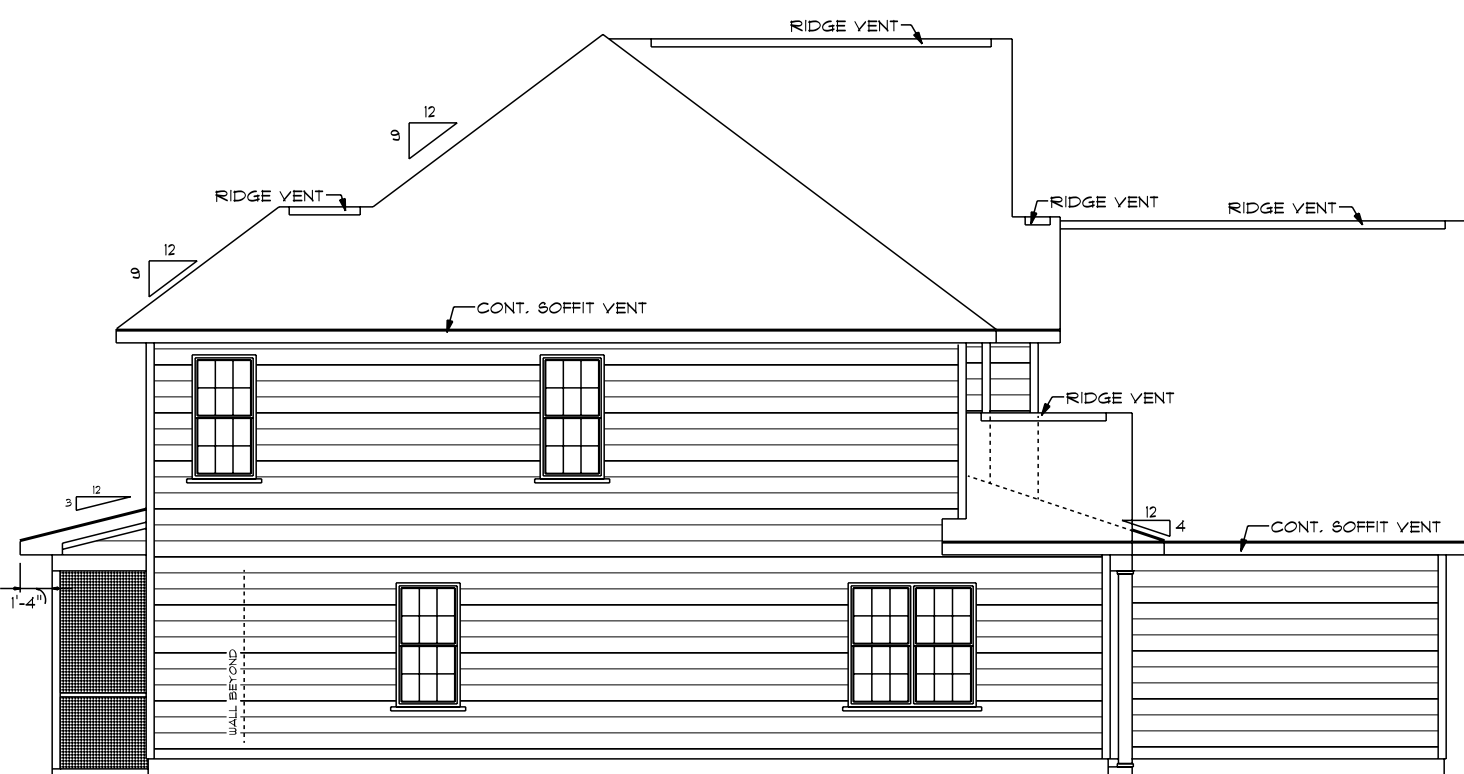


LEFT ELEVATION
 SCALE: 1/8" = 1'0"

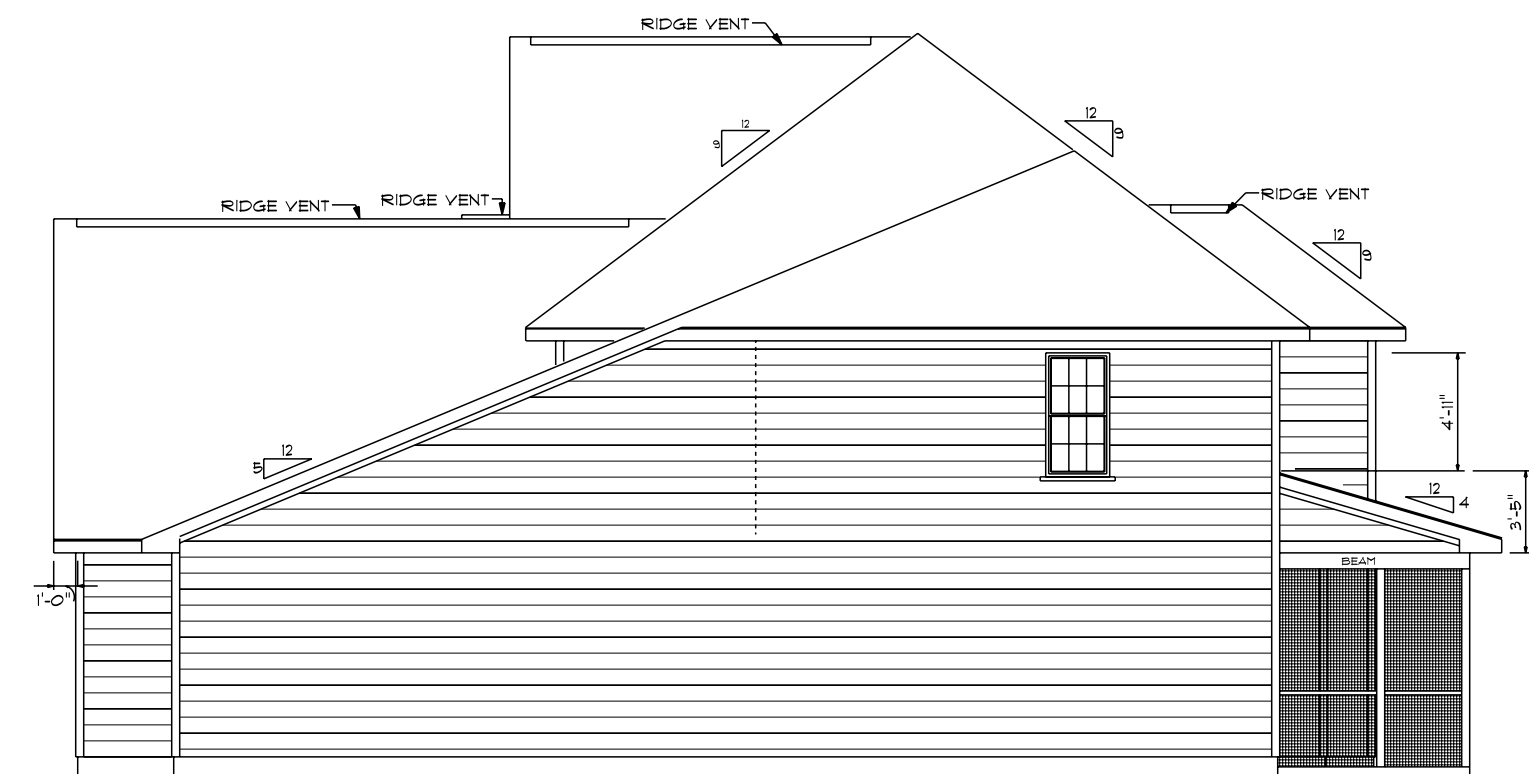

RIGHT ELEVATION
 SCALE: 1/8" = 1'0"

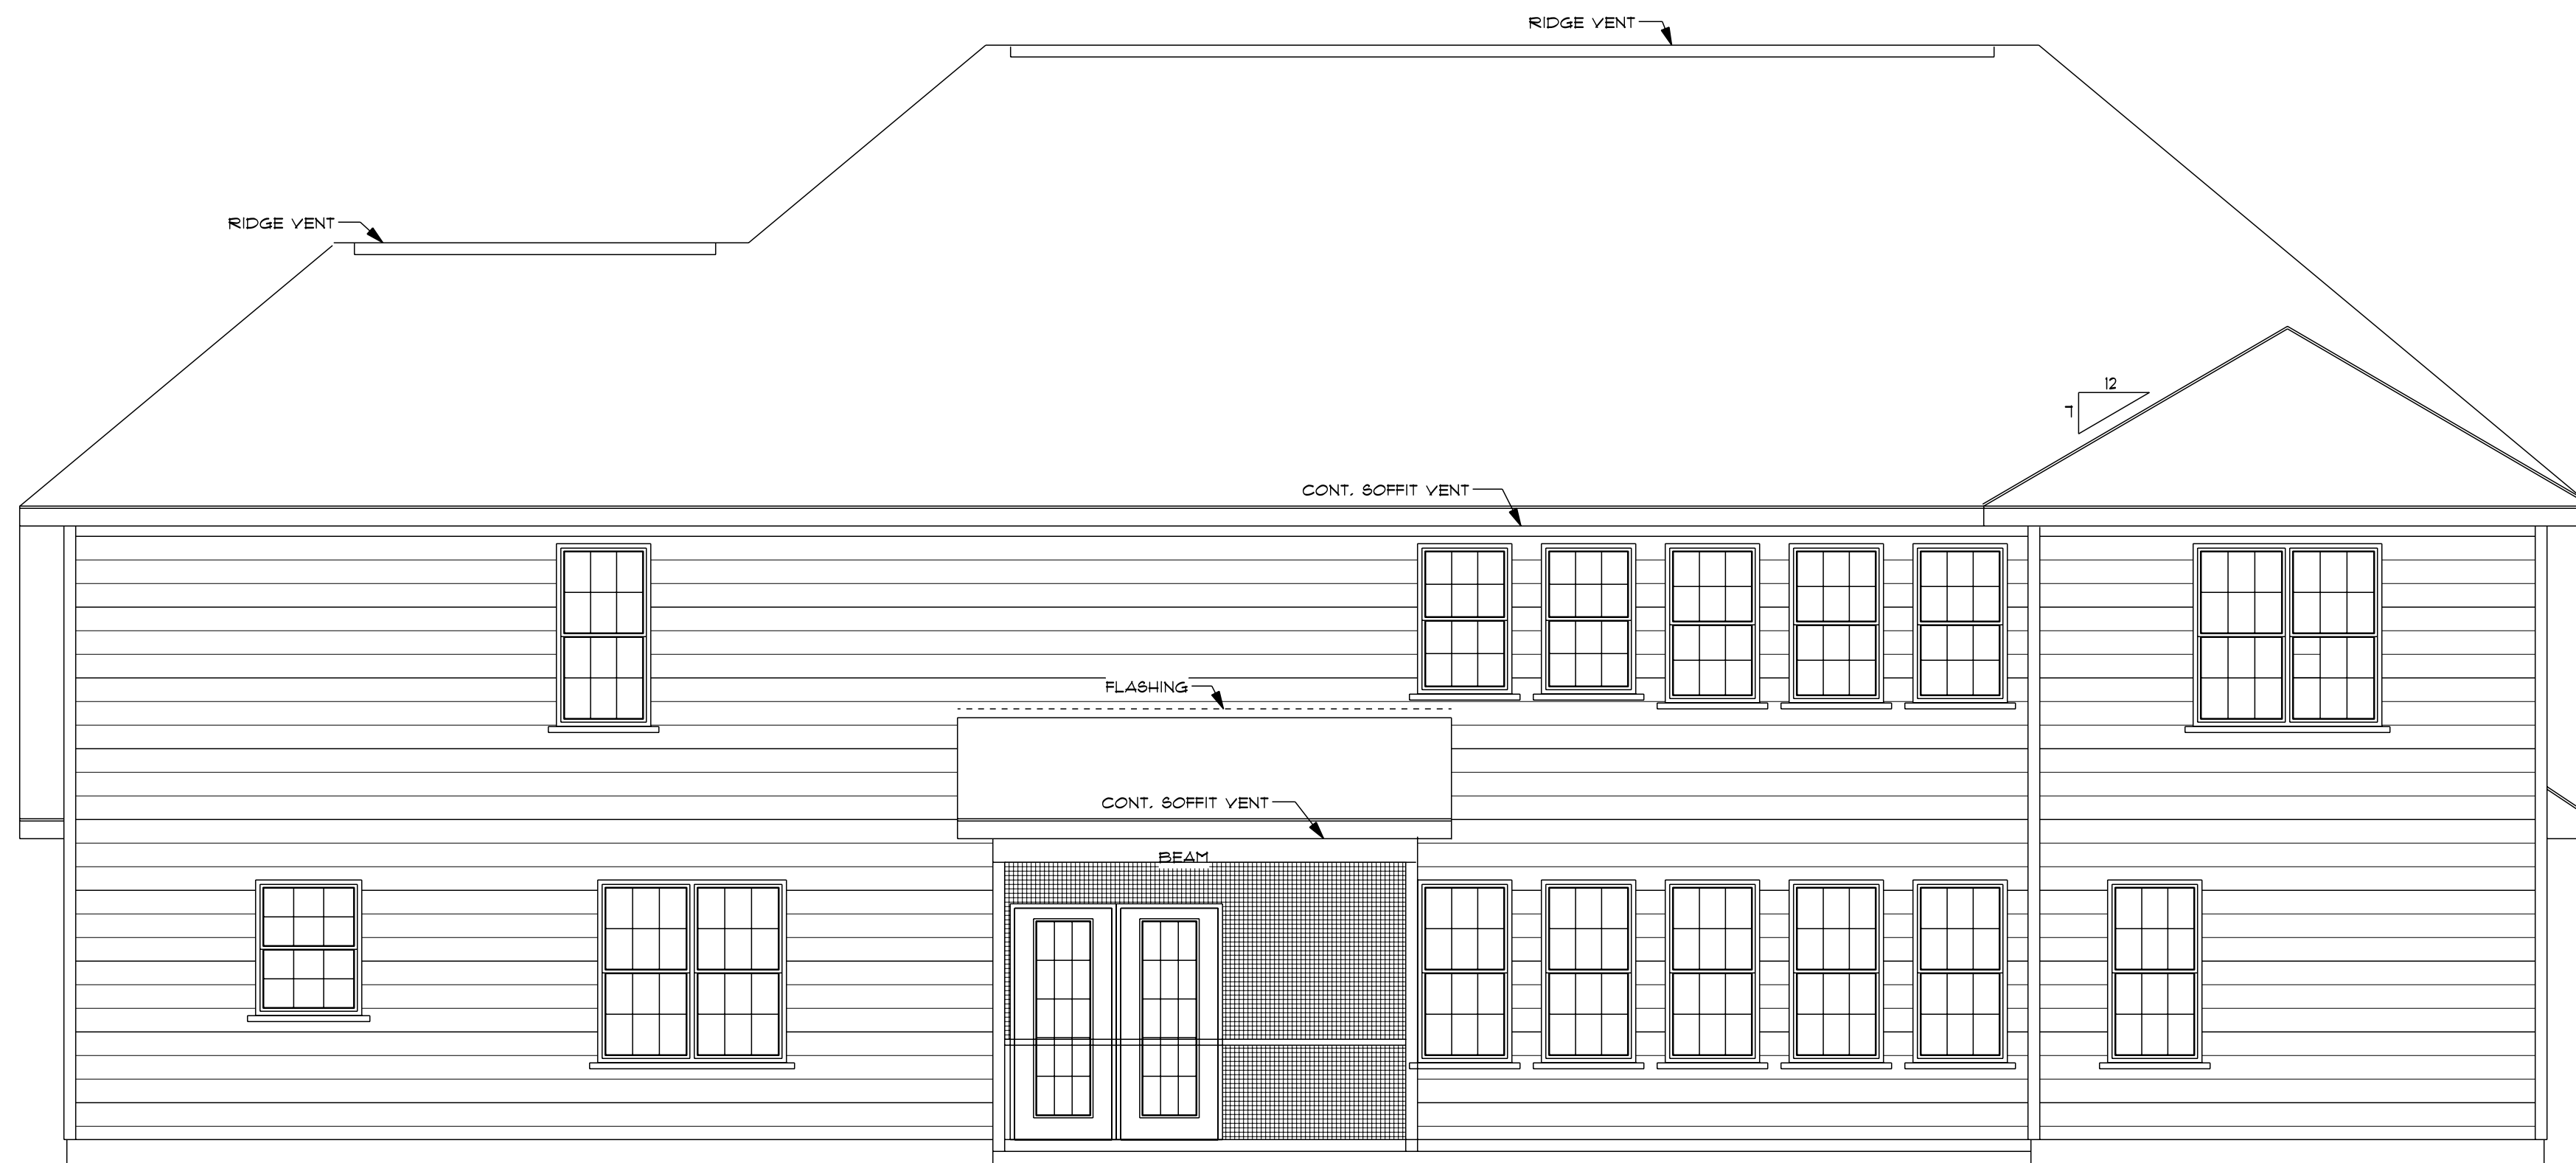


REAR ELEVATION
 SCALE: 1/4" = 1'0"

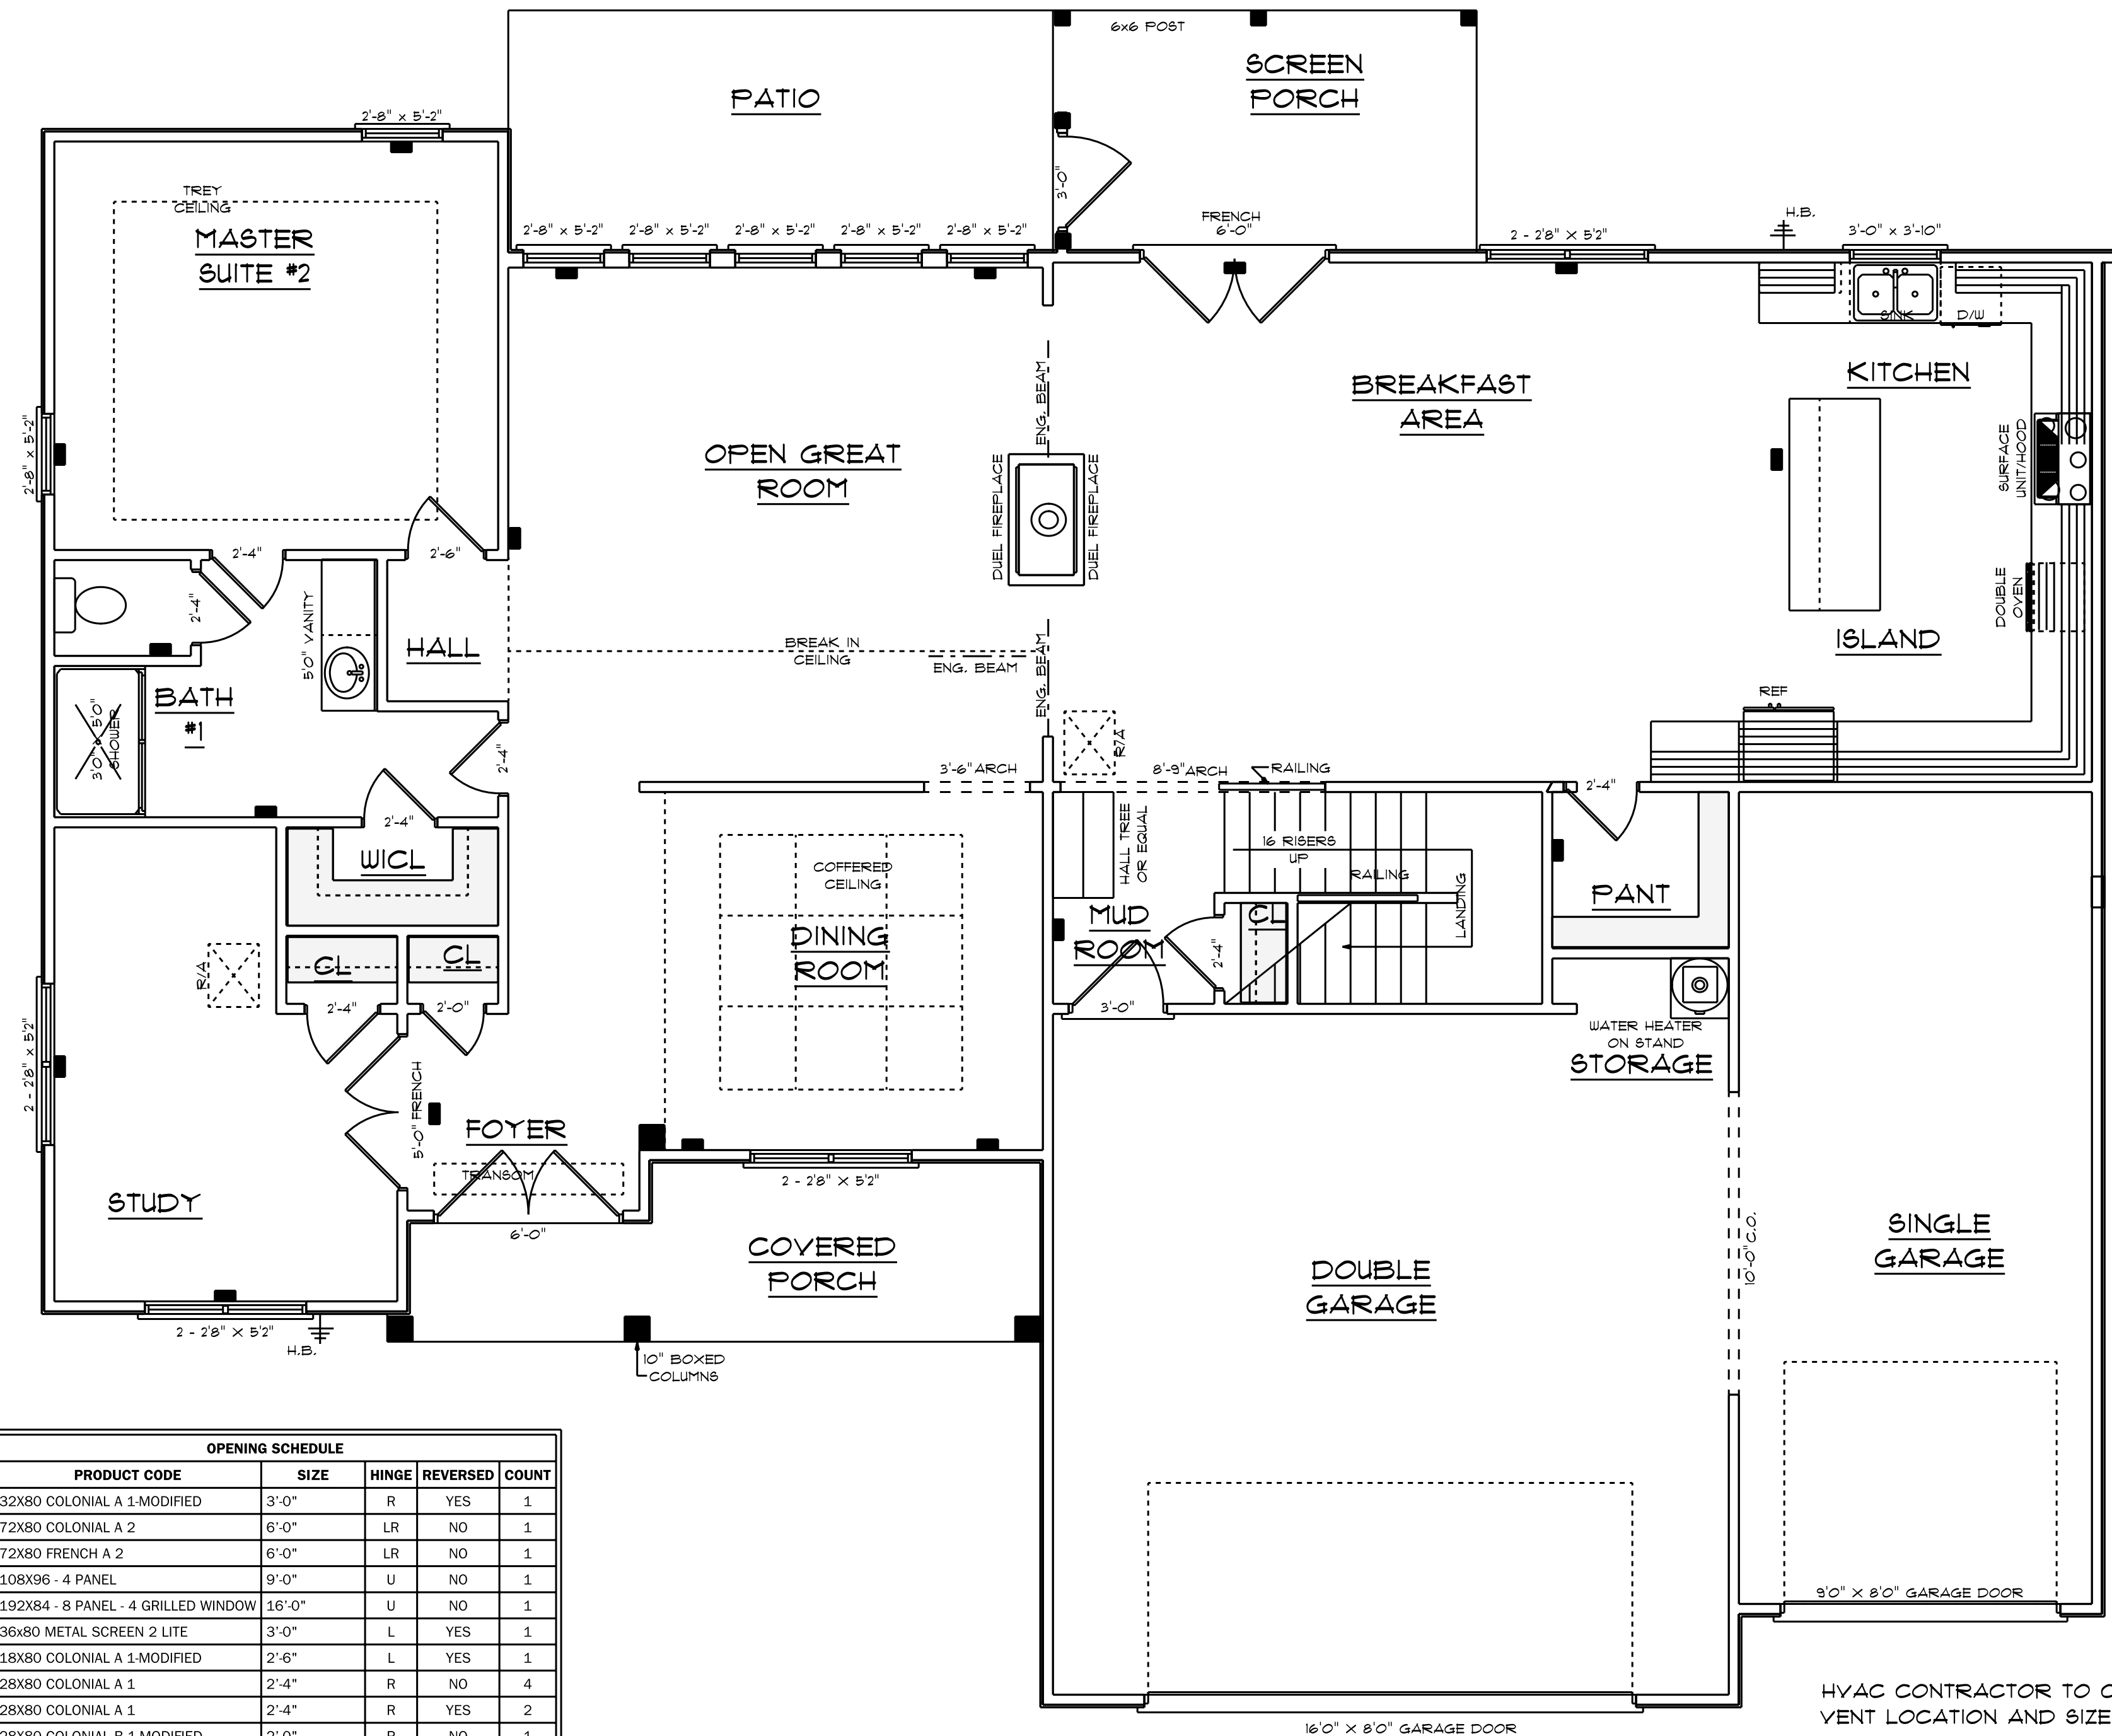

9'0" FINISHED CEILING HEIGHT ON FIRST FLOOR
 1'4" WINDOW HEADER HEIGHT ON FIRST FLOOR
 8'0" FINISHED CEILING HEIGHT ON SECOND FLOOR
 6'8" WINDOW HEADER HEIGHT ON SECOND FLOOR

HVAC PLAN
 FIRST FLOOR
 SCALE: 1/4" = 1'0"

1911 S/F ON FIRST FLOOR
 1880 S/F ON SECOND FLOOR
 3791 S/F TOTAL HEATED AREA
 582 S/F IN DOUBLE GARAGE
 326 S/F IN SINGLE GARAGE
 110 S/F ON FRONT PORCH
 119 S/F ON REAR PORCH

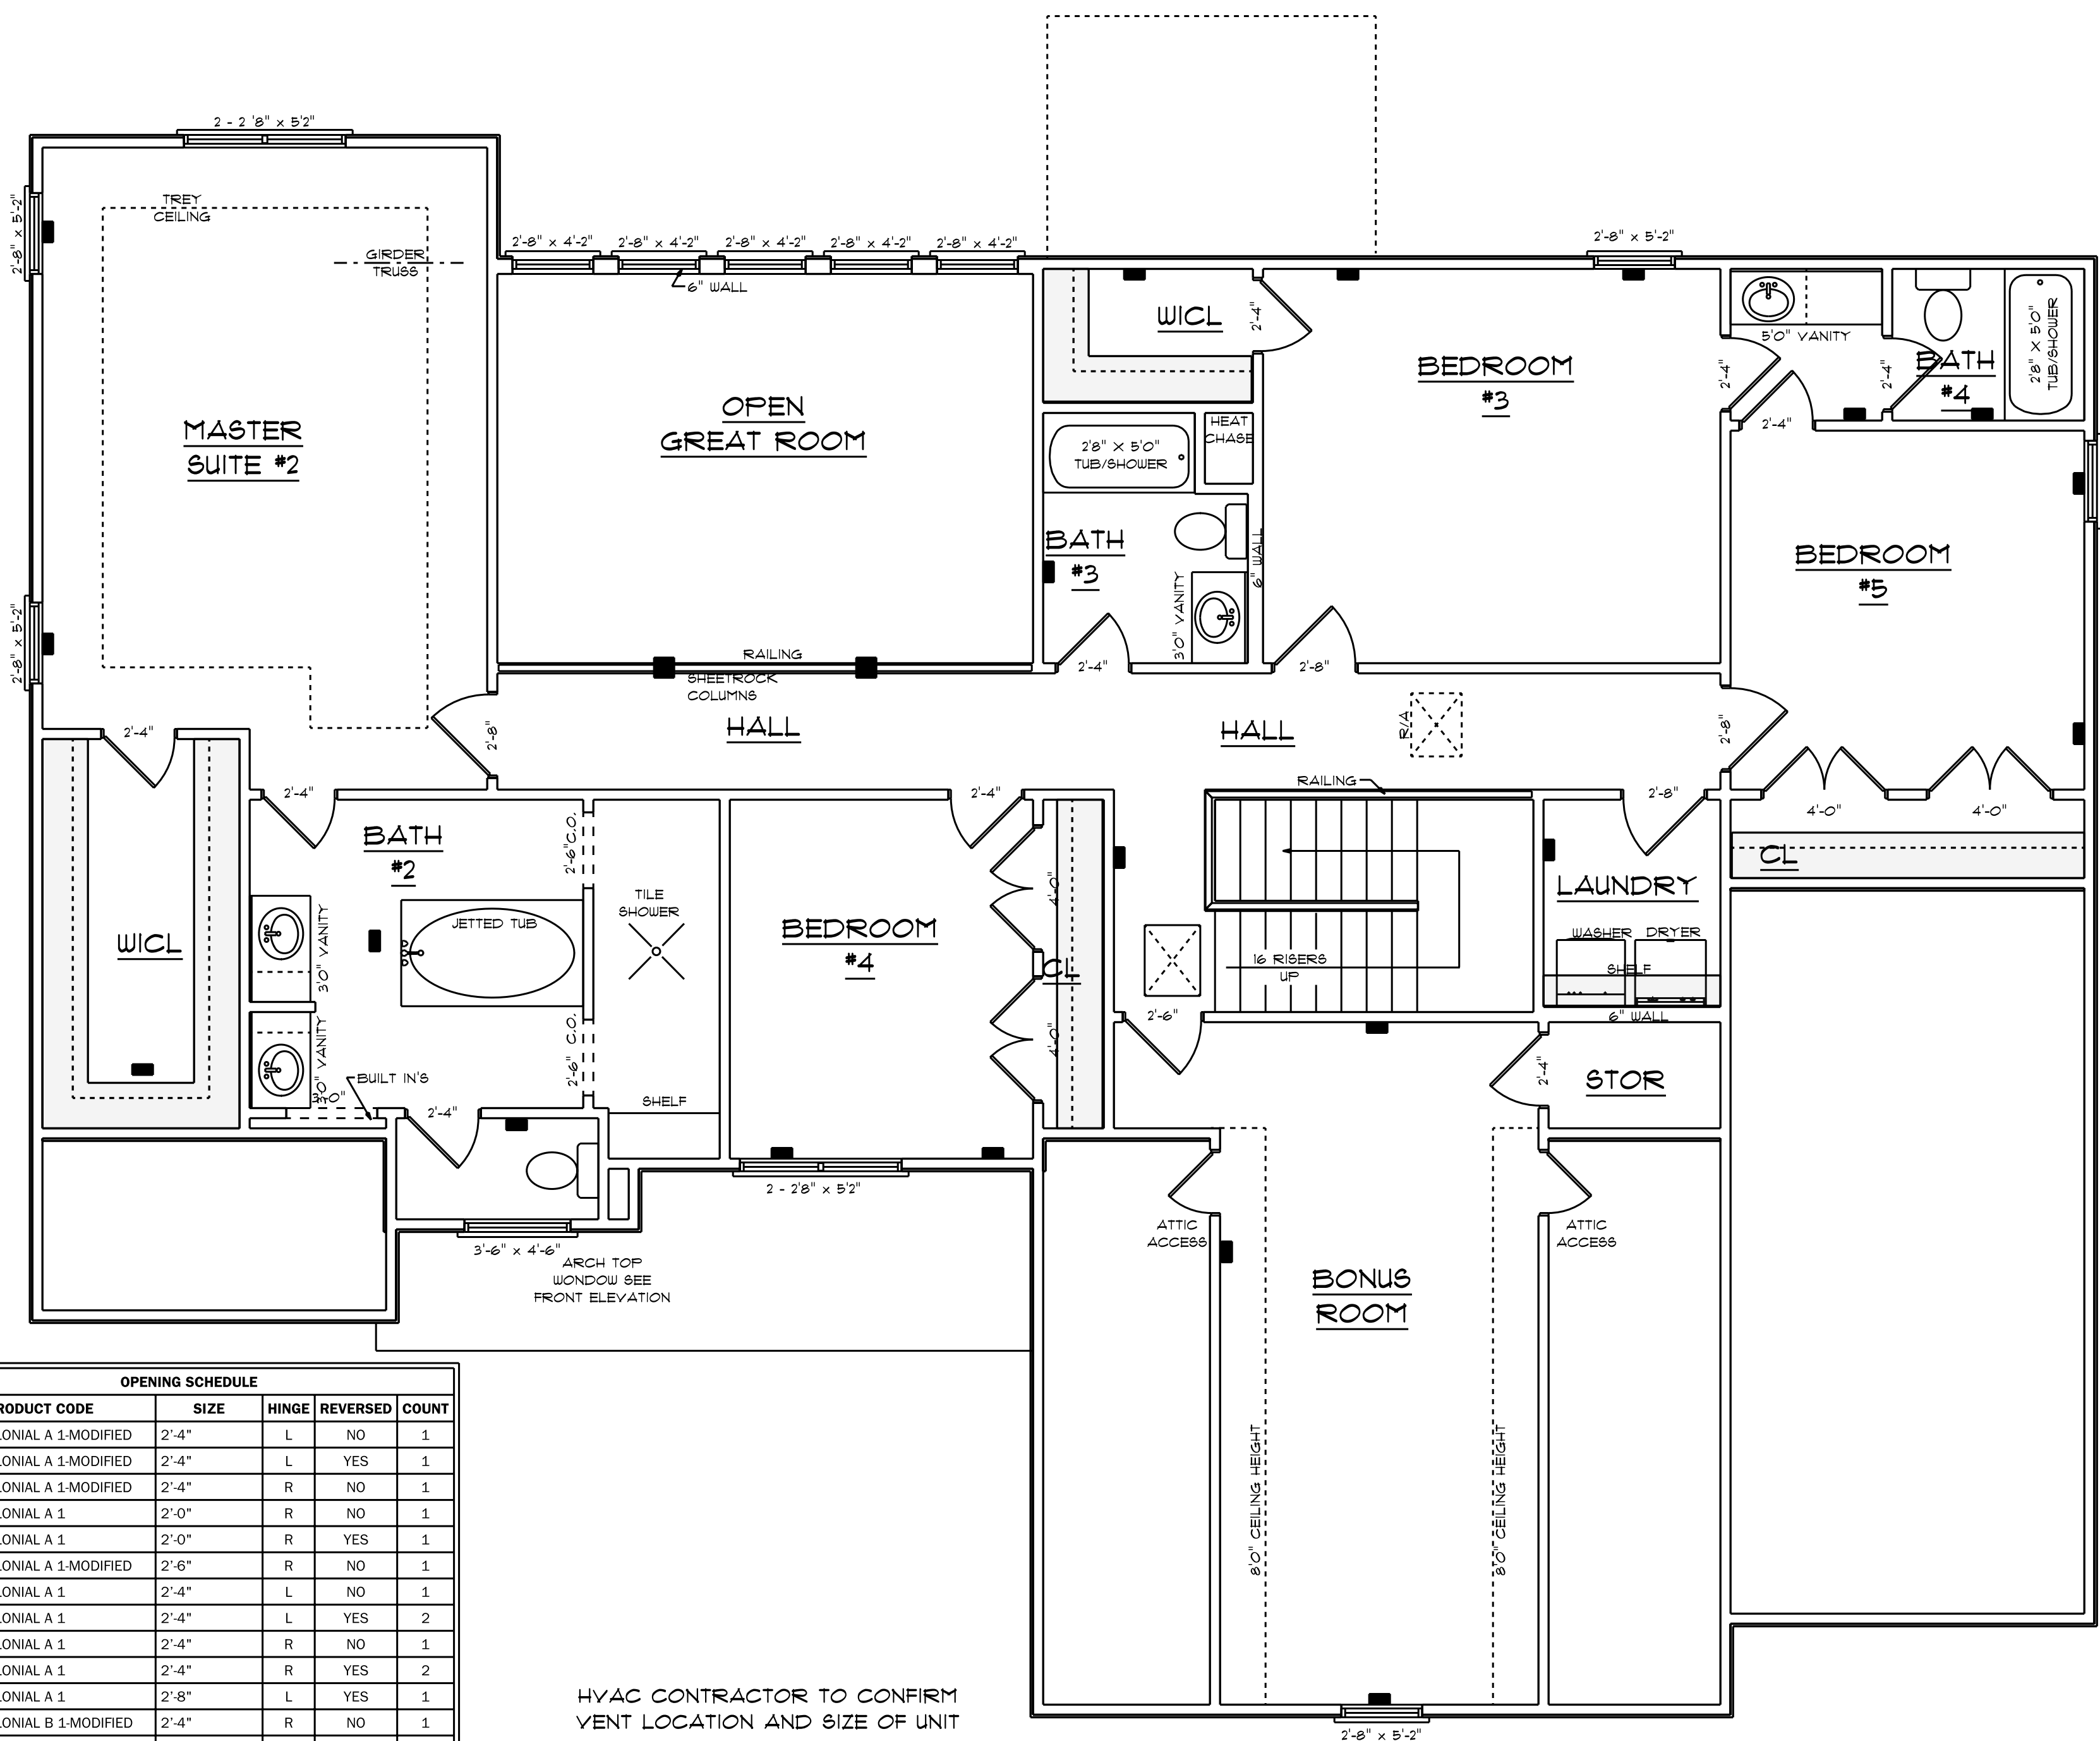

OPENING SCHEDULE				
PRODUCT CODE	SIZE	HINGE	REVERSED	COUNT
18X80 COLONIAL A 1-MODIFIED	2'-4"	L	NO	1
18X80 COLONIAL A 1-MODIFIED	2'-4"	L	YES	1
18X80 COLONIAL A 1-MODIFIED	2'-4"	R	NO	1
24X80 COLONIAL A 1	2'-0"	R	NO	1
24X80 COLONIAL A 1	2'-0"	R	YES	1
28X80 COLONIAL A 1-MODIFIED	2'-6"	R	NO	1
28X80 COLONIAL A 1	2'-4"	L	NO	1
28X80 COLONIAL A 1	2'-4"	L	YES	2
28X80 COLONIAL A 1	2'-4"	R	NO	1
28X80 COLONIAL A 1	2'-4"	R	YES	2
32X80 COLONIAL A 1	2'-8"	L	YES	1
32X80 COLONIAL B 1-MODIFIED	2'-4"	R	NO	1
32X80 COLONIAL B 1	2'-8"	L	NO	1
32X80 COLONIAL B 1	2'-8"	R	YES	1
32X80 PLAIN 1	2'-8"	L	NO	1
48X80 COLONIAL A 2	4'-0"	LR	YES	2
48X80 COLONIAL C 2-MODIFIED	4'-0"	LR	YES	2
18X24 DOUBLE HUNG 1-MODIFIED	2 - 2'-8" x 5'-2"	NN	NA	1
18X24 DOUBLE HUNG 1-MODIFIED	2'-8" x 4'-2"	N	NA	5
18X24 DOUBLE HUNG 1-MODIFIED	2'-8" x 5'-2"	N	NA	5
18X24 DOUBLE HUNG 1-MODIFIED	3'-6" x 4'-6"	N	NA	1
18X24 DOUBLE HUNG 1-MODIFIED	5'-4" x 5'-2"	NN	NA	1

HVAC CONTRACTOR TO CONFIRM VENT LOCATION AND SIZE OF UNIT

**HVAC PLAN
SECOND FLOOR**

SCALE: 1/4" = 1'0"

1880 S/F ON SECOND FLOOR